
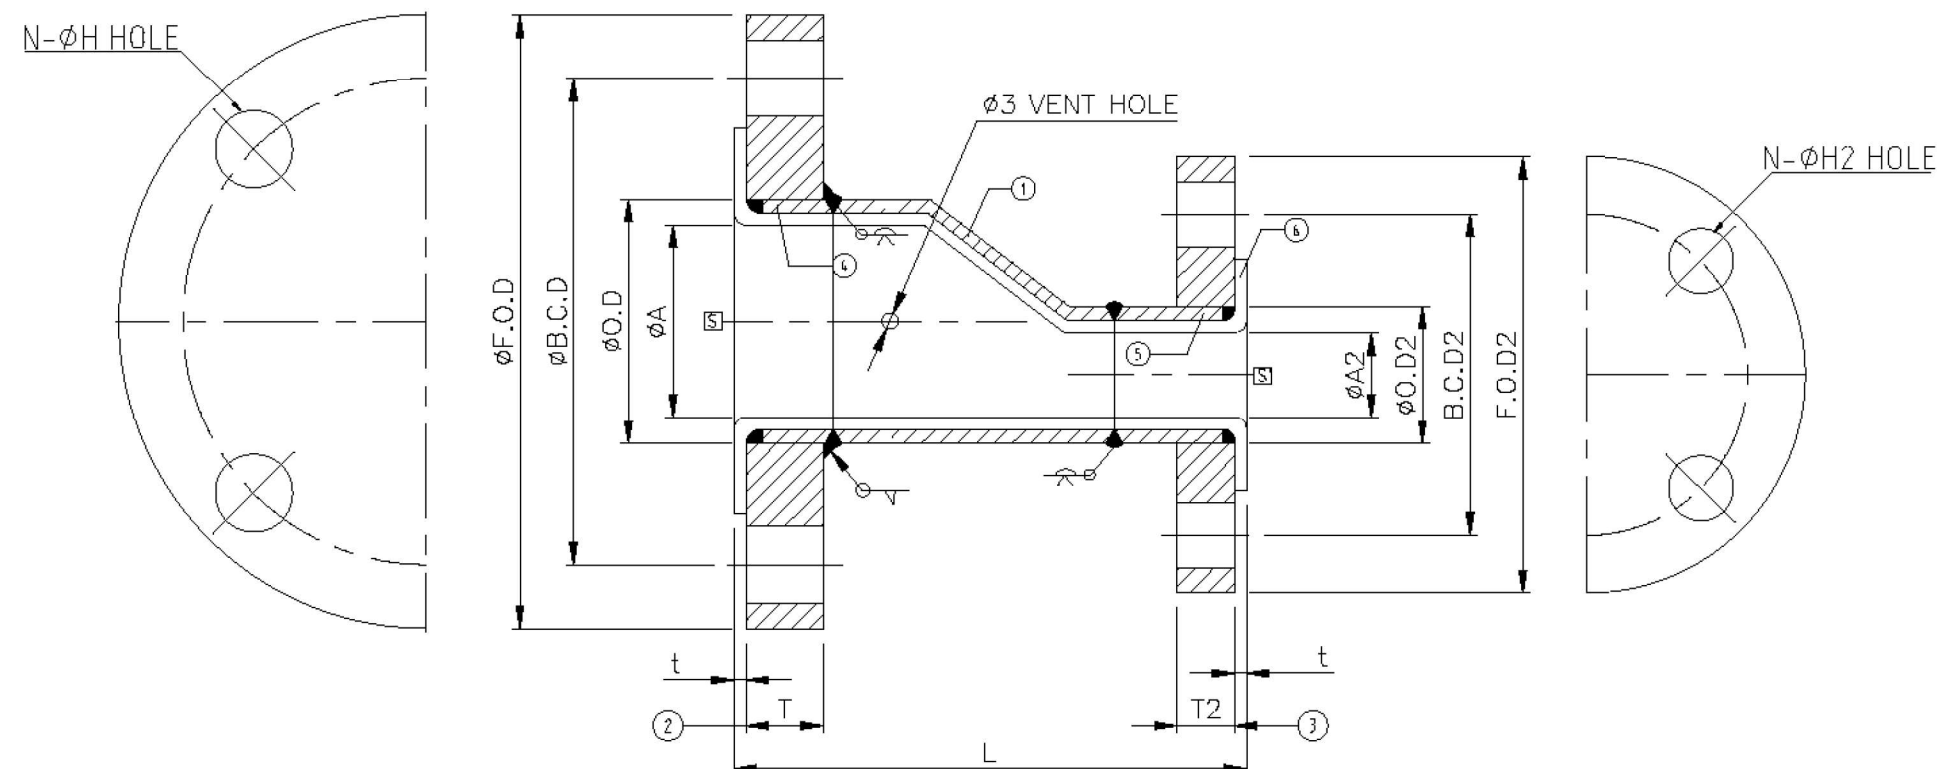


ECC REDUCER

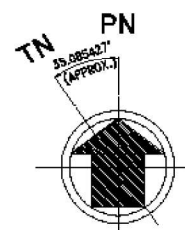

* DIMENSIONS & FEATURES

ITEM	SIZE		FACE TO FACE		LINER T(MIN)	Ident Code	Weight(kg)
	S	S'	L	TOLERANCE			
PTFE LINED ECC REDUCER	4"	1-1/2"	152		4.0	I49288691	8.2
		2"	152		4.0	I49288692	10.0
		3"	152	±3.0	4.0	I49288694	12.0
	6"	3"	200		5.0	I49288697	16.0
		4"	200		5.0	I49288698	18.0
	8"	6"	200		5.0	I121674854	28.0

SIZE	PIPE O.D	FLANGE (ANSI 150#)					
		ØA	ØF.O.D	ØB.C.D	N-ØH	T	
ANSI 150#	ØO.D	ØA2	ØF.O.D2	ØB.C.D2	N-ØH2	T2	
3/4"	26.7	16	98.6	69.9	4-Ø16	12.7	
1"	33.4	22	108.0	79.2	4-Ø16	14.2	
1-1/2"	48.3	36	127.0	98.5	4-Ø16	17.5	
2"	60.3	47	152.4	120.6	4-Ø19	19.1	
2-1/2"	73.0	60	177.8	139.7	4-Ø19	22.4	
3"	88.9	73	190.5	152.4	4-Ø19	23.9	
4"	114.3	94	228.6	190.5	8-Ø19	23.9	
6"	168.3	143	279.4	241.3	8-Ø22	25.4	
8"	219.1	192	342.9	298.4	8-Ø22	28.5	

UNIT : mm

No.	DESCRIPTION	MATERIAL	Q'TY	REMARKS
1	BEND	A234-WPB	1	SCH40
2	FLANGE	A105	1	ANSI 150#
3	FLANGE	A105	1	ANSI 150#
4	PIPE	A106	1	SMLS SCH40
5	PIPE	A106	1	SMLS SCH40
6	LINER	PTFE	1	SEE TABLE

VENDOR DATA STATUS

☐ R : FOR REVIEW ☐ I : FOR INFORMATION

☐ A : FOR APPROVAL ☐ C : FOR CONSTRUCTION

☐ A1 Approved without comments

☐ A2 Approved with comments, re-submit not required

☐ A3 Approved with comments, re-submit for review

☐ A4 Not Approved, re-submit for approval

☐ R1 No Comments

☐ R2 Comments as noted

This permission to proceed or review taken on Vendor Data shall not relieve vendor from its responsibilities and liabilities under purchase order.

DATE: CHECK: APPROV.:

REV.	DATE	DESCRIPTION	DRN	CK	RW	APP
0	01/07/2020	ISSUED FOR CONSTRUCTION	H.S.CHOI	S.B.CHOI	-	I.S.HWANG
C	24/06/2020	ISSUED FOR REVIEW	H.S.CHOI	S.B.CHOI	-	I.S.HWANG
B	02/04/2020	ISSUED FOR REVIEW	H.S.CHOI	S.B.CHOI	-	I.S.HWANG
A	19/03/2020	ISSUED FOR REVIEW	H.S.CHOI	S.B.CHOI	-	I.S.HWANG
DRN.	H.S.CHOI	CK.	S.B.CHOI	RW.	-	APP. I.S.HWANG

THIS DRAWING IS THE PROPERTY OF LONG SON PETROCHEMICALS COMPANY LIMITED
NOT BE REPRODUCED, COPIED, LENT OR OTHERWISE DISPOSED OF WITHOUT WRITTEN CONSENT OF LSP
NOR USED FOR ANY PURPOSE OTHER THAN THAT FOR WHICH IS FURNISHED

PROJECT
PETROCHEMICAL COMPLEX IN SOUTH OF VIETNAM
TỔ HỢP HÓA DẦU MÌN NAM VIỆT NAM
PACKAGE G – CENTRAL UTILITY PLANT

COMPANY
LONG SON
PETROCHEMICALS
LONG SON PETROCHEMICALS CO., LTD.

EPC CONTRACTOR
HYUNDAI
ENGINEERING CO., LTD.
HYUNDAI ENGINEERING CO., LTD.

FABRICATOR
FOOSUNG
FOOSUNG PRECISION IND. CO., LTD.

TITLE
DRAWING

DOCUMENT CLASS 1	DWG NO. UT1-2P90-119003	REV. 8/21
SCALE N/S	EQUIP. NO. / TAG NO. -	
	LSP DOCUMENT NO. UT1-2P90-119003	